



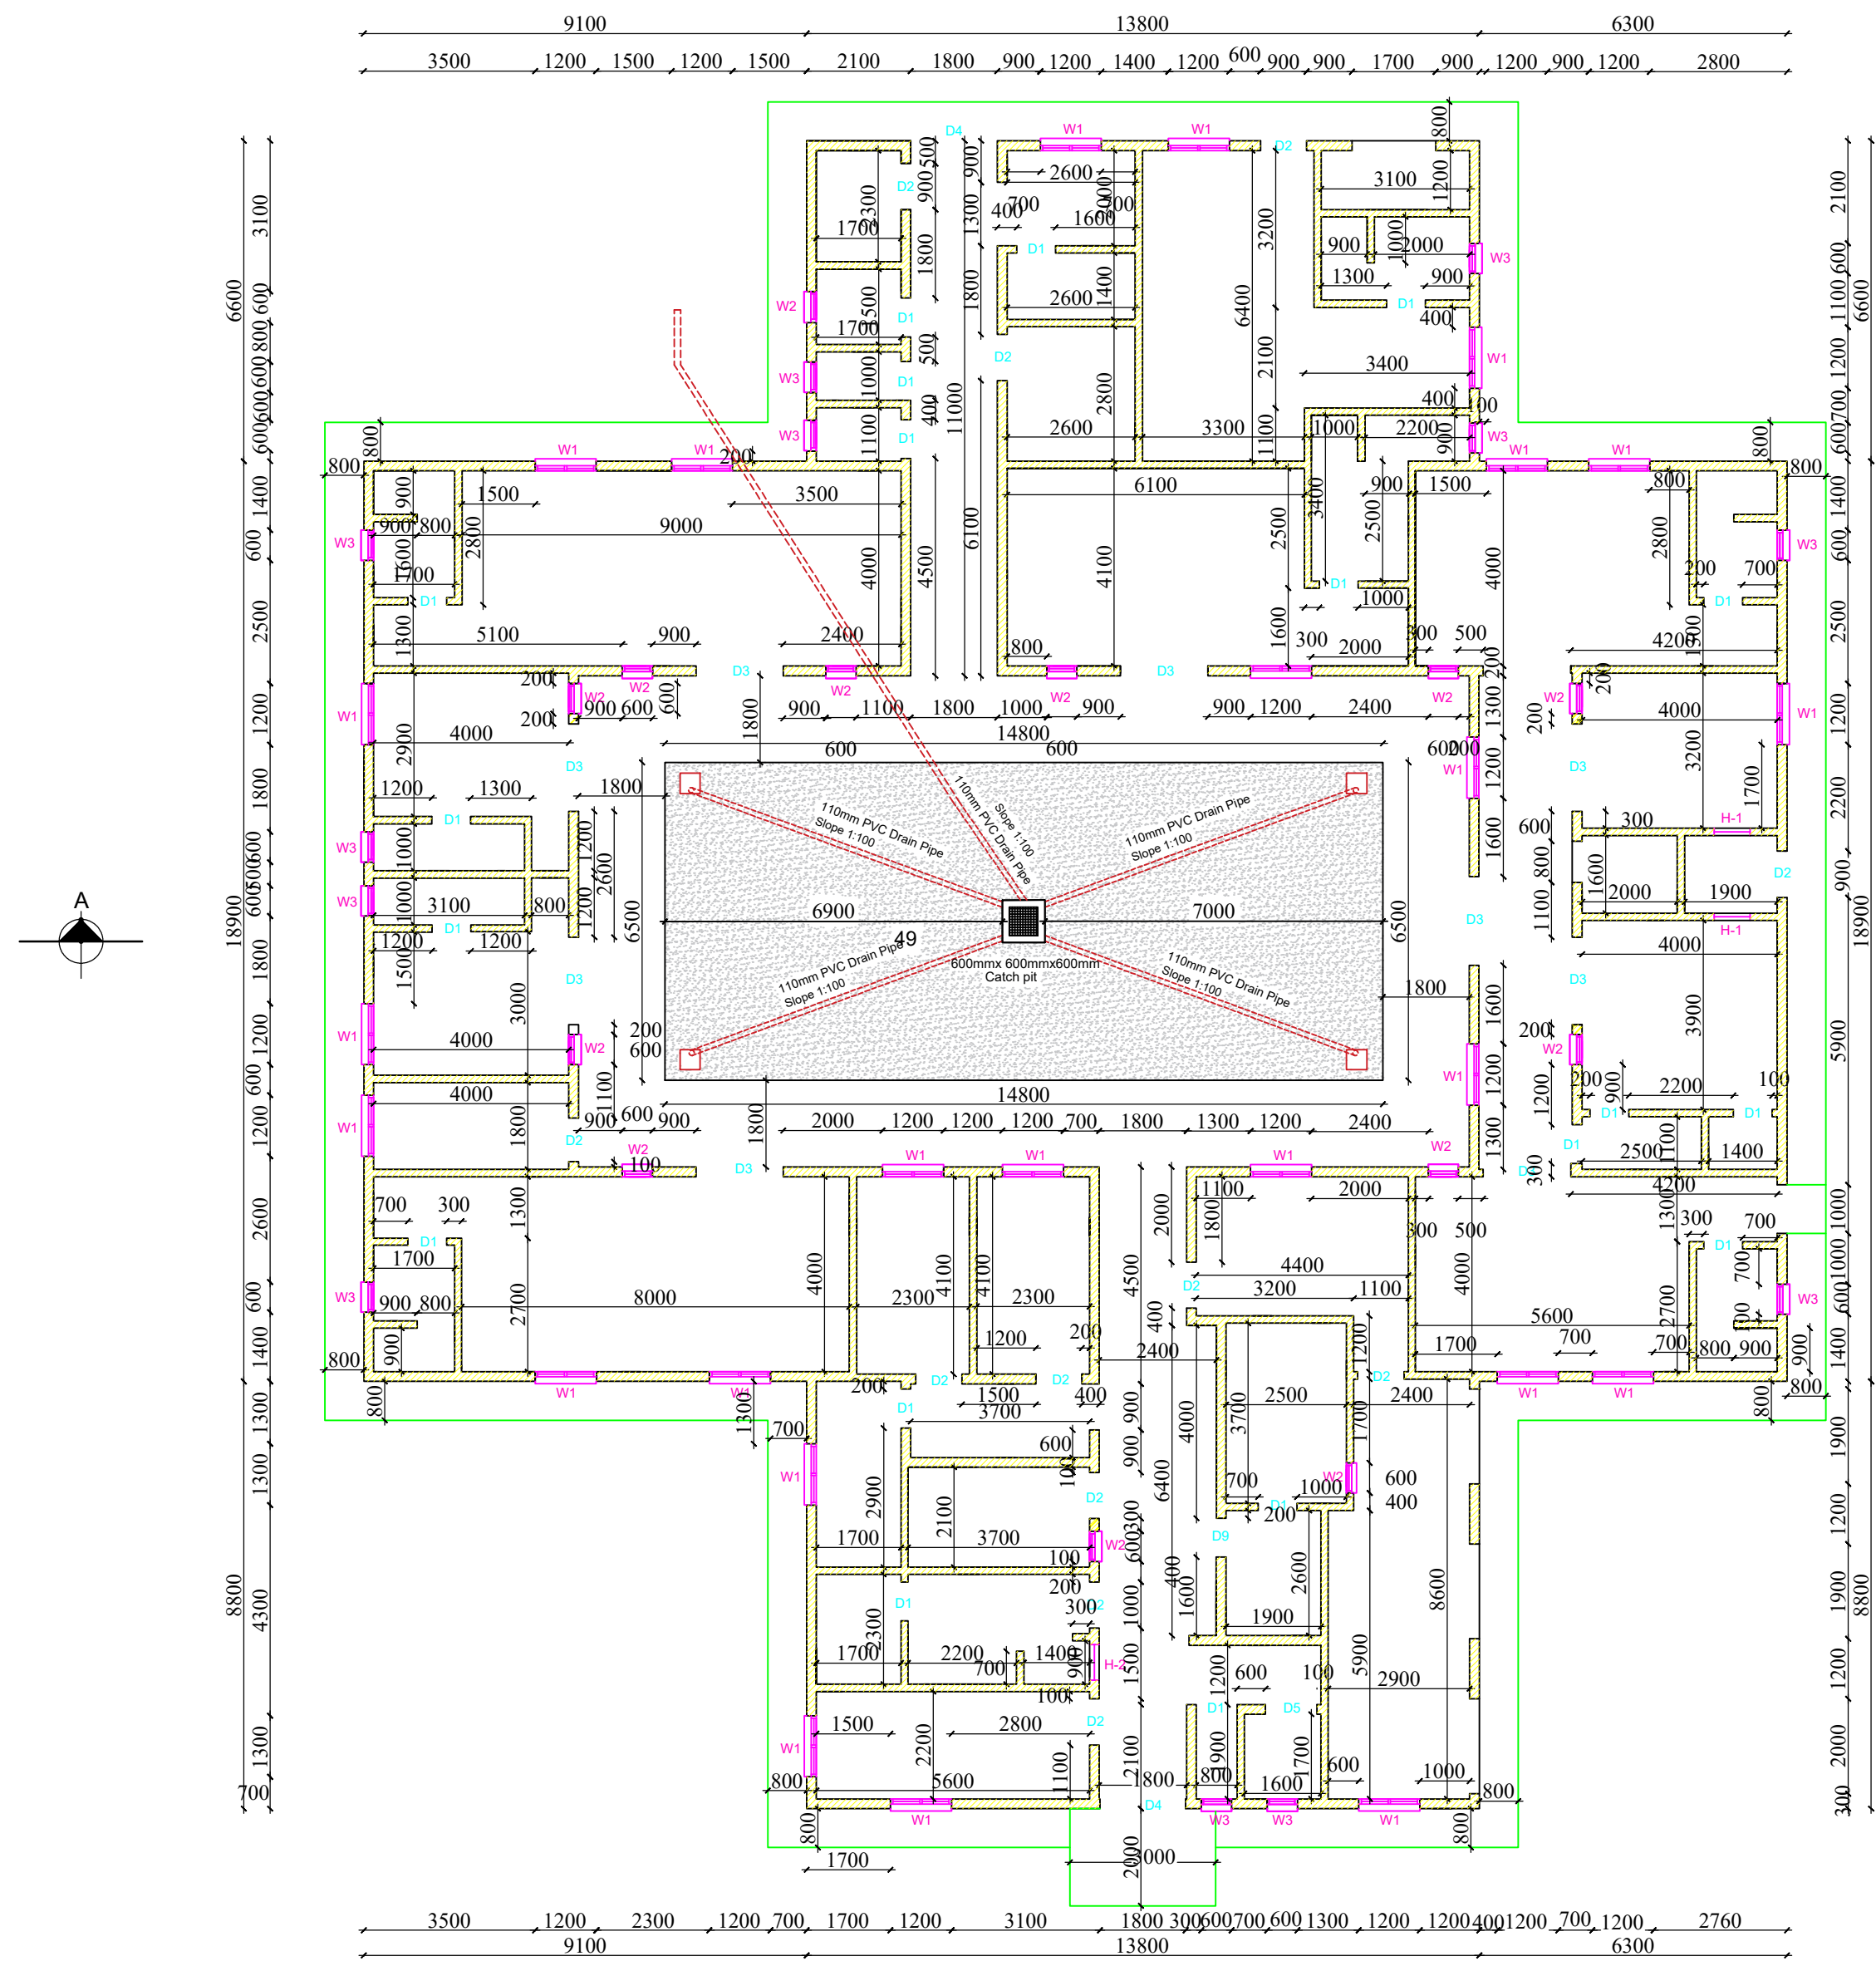

Floor Plan

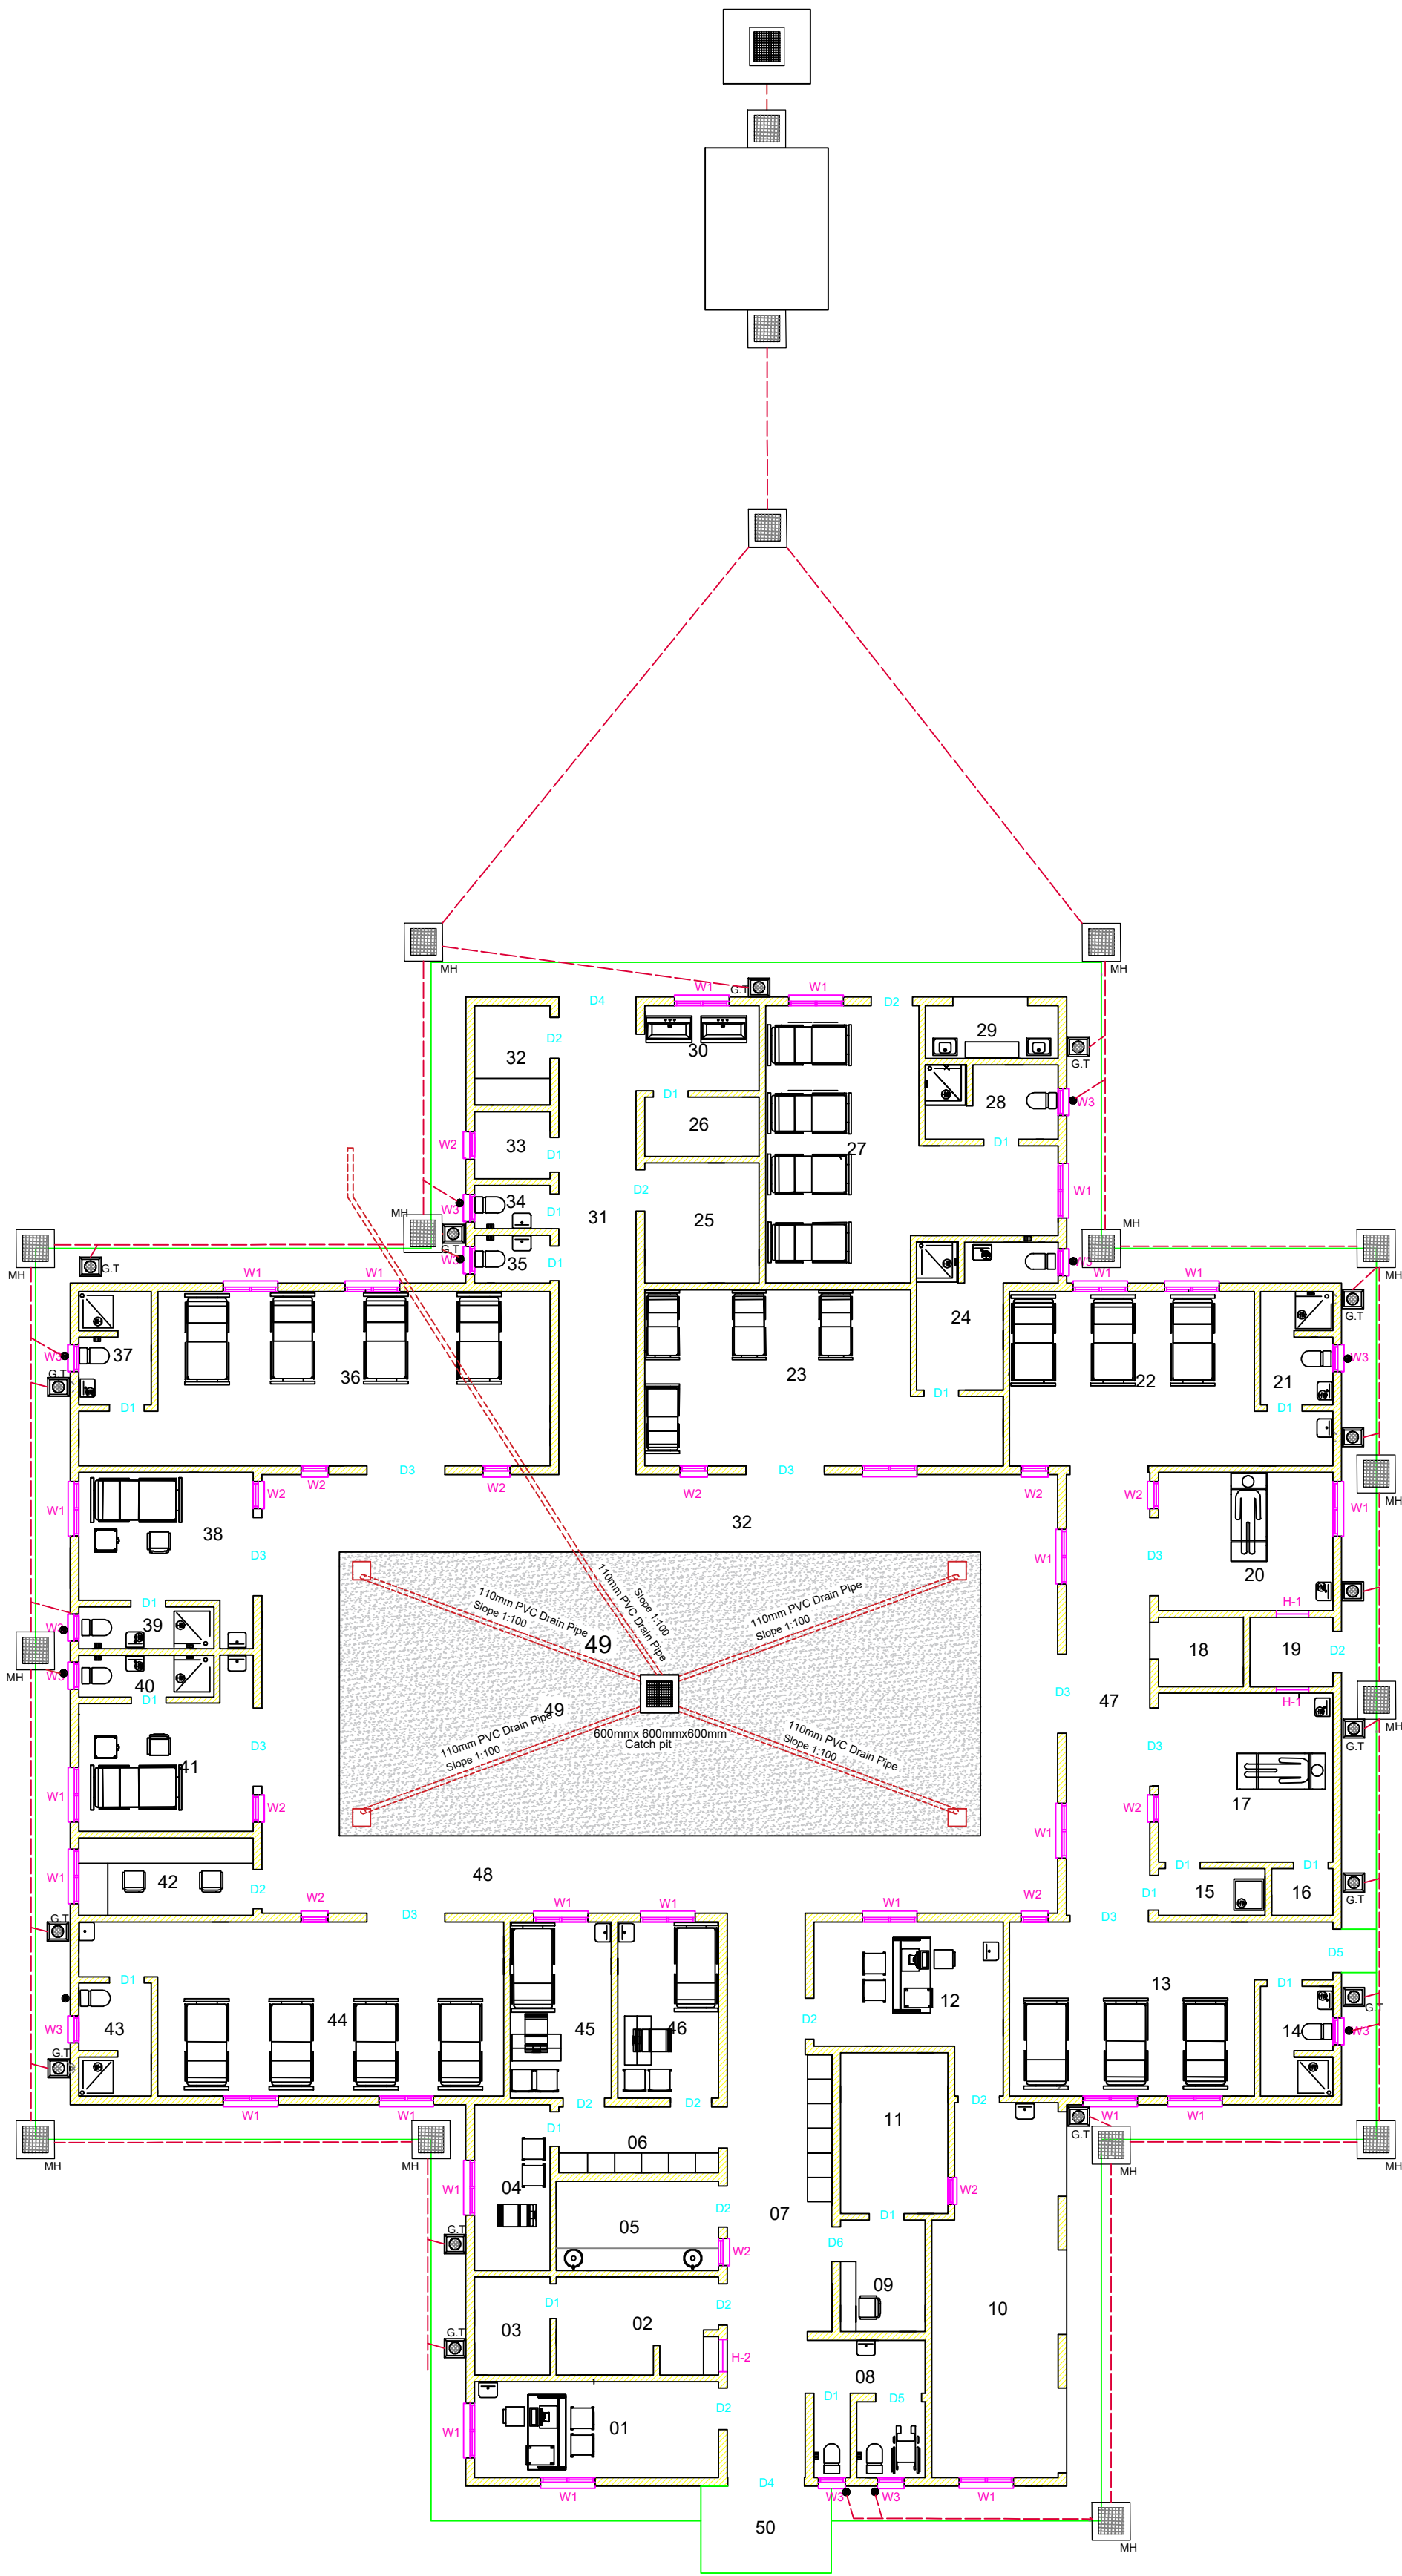

Floor Plan, Veranda and Apron

ROOM LIST

- 01 Environmental Health Office
- 02 Dispensary
- 03 Store
- 04 Anti Retroviral Therapy - A.R.T
- 05 Laboratory
- 06 Waiting Area
- 07 Entrance Corridor
- 08 Public WCs (Fem. and Disabled Persons)
- 09 Reception
- 10 External Waiting Area
- 11 Records Room
- 12 Counseling Room
- 13 Pre-Natal Ward (3 Beds)
- 14 WC & Shower (Pre-Natal Ward)
- 15 Scrub Room
- 16 Clean Store
- 17 Minor Operating Theater (O.R)
- 18 Nurses' Station
- 19 Dirty Utility (After OR and Delivery)
- 20 Delivery Room
- 21 WC & Shower (Post-Natal Ward)
- 22 Post-Natal Ward (3 Beds)
- 23 Pediatric Ward (4 Beds)
- 24 WC & Shower (Ped. Ward)
- 25 Bulk Storage
- 26 Linen Storage
- 27 Mother's Shelter
- 28 WC & Shower (Mother's Shelter)
- 29 Food Preparation Area
- 30 Laundry Room
- 31 Service Corridor
- 32 Electrical Store
- 33 General Store
- 34 WC Male
- 35 WC Female
- 36 Female Ward (4 Beds)
- 37 WC & Shower (Female Ward)
- 38 Isolation Ward (Female)
- 39 WC & Shower (Female Isolation)
- 40 WC & Shower (Male Ward)
- 41 Isolation Ward (Male)
- 42 Nurses' Station and Locker Room
- 43 WC & Shower (Male Ward)
- 44 Male Ward (4 Beds)
- 45 Exam Room 1
- 46 Exam Room 2
- 47 Medical Corridor
- 48 Courtyard Corridor
- 49 Central Courtyard
- 50 Entrance Apron

GENERAL NOTES

- CWS - COLD WATER SUPPLY
- SVP - SEWER VENT PIPE
- G.T - GULLY TRAP
- F.D - FLOOR DRAIN
- WC - WATER CLOSET
- WHB - WASH HAND BASIN
- MH - MAN HOLE
- WP - WASTE PIPE

- All sewer pipes to be heavy duty UPVC.
- All waste pipes from the Urinals to connect to sewer pipes not gully traps
- All gully traps to be 400m x 300m.
- All vent pipes to have vent valves.
- Slope to be 1:80 for new sewer line with first manhole being 600mm deep.
- All manholes to be 900 x 900mm.
- All sanitary fittings to be cobra type or vaal type or equal and approved by the engineer
- All sewer pipes passing under drive ways to be put in G.I SLEEVES

- Backfill materials around the pipes to be clean, sieved subsoil or river sand of particle size not exceeding 6.0mm
- The bottom of the pipe trenches are to be well compacted to 93% Mod. AASHTO.
- Backfill materials other than the ones described above shall be the surplus of the excavated soil, free from refuse and vegetable matter. This shall be compacted in well watered layers not exceeding 150mm thick.
- For pipes crossing roadways, place pipe in fibre cement pipe sleeves of at least 1.5xpipe diameter

CLIENT

MINISTRY OF HEALTH

PROJECT

PROPOSED CONSTRUCTION:
THE MATUWA MINI HOSPITAL IN
SIAVONGA DISTRICT - SOUTHERN
PROVINCE

DESCRIPTION

FLOOR PLAN, ROOM LIST

ROOM LIST

DATE APRIL 2026	APPROVED BY MoH - INFRASTRUCTURE PS MWANZA ZIA
DESIGNED BY NDILILA ASSOCIATES REVISED BY ZAMBEZI RIVER AUTHORITY	SCALE 1:100
DWG NO.	